

DATE:	11/3/2023
PROJECT/JOB#:	222006 Milford Medium Voltage Loop Completion - Rebid
ADDENDUM #:	1

*Below is a summary of contract document changes included in this addendum. This is not an exhaustive list of the changes. Contractor is responsible for reviewing all attachments for document changes. Include pricing for work summarized in text below **AND** contained in the document revisions.*

REQUEST FOR PROPOSAL

Advertisement for bid

1. Request for Proposal
 - a. Item IV Proposals. Revise Item A to Read: "Proposals due: 2:00 CDT Thursday, November 9, 2023."

ELECTRICAL

Drawings


1. Sheet E100 – Electrical Site Plan
 - a. Sheet reissued
2. Sheet E200 – electrical Details
 - a. Sheet reissued

QUESTIONS & ANSWERS

Bid Questions and Answers are summarized below. Questions may be paraphrased. Answers provided include scope that is hereby made part of the contract.

1. Question: Do you have a detail and specs for the pad mount switch concast deep pad box, manufacturers specs, etc?
 - a. Concast is the manufacturer of precast deep pad box specifically designed for the S & C switch specified. www.concastinc.com
2. Question: Do you have a trench detail of what you want? Base spacer chairs, rebar, depth requirements, etc?
 - b. Detail added by this addendum.
3. Question: As far as a testing agency, do you want SCC to hire directly or the contractor to be responsible for the testing?
 - a. The testing agency will be hired directly by SCC.

END OF ADDENDUM

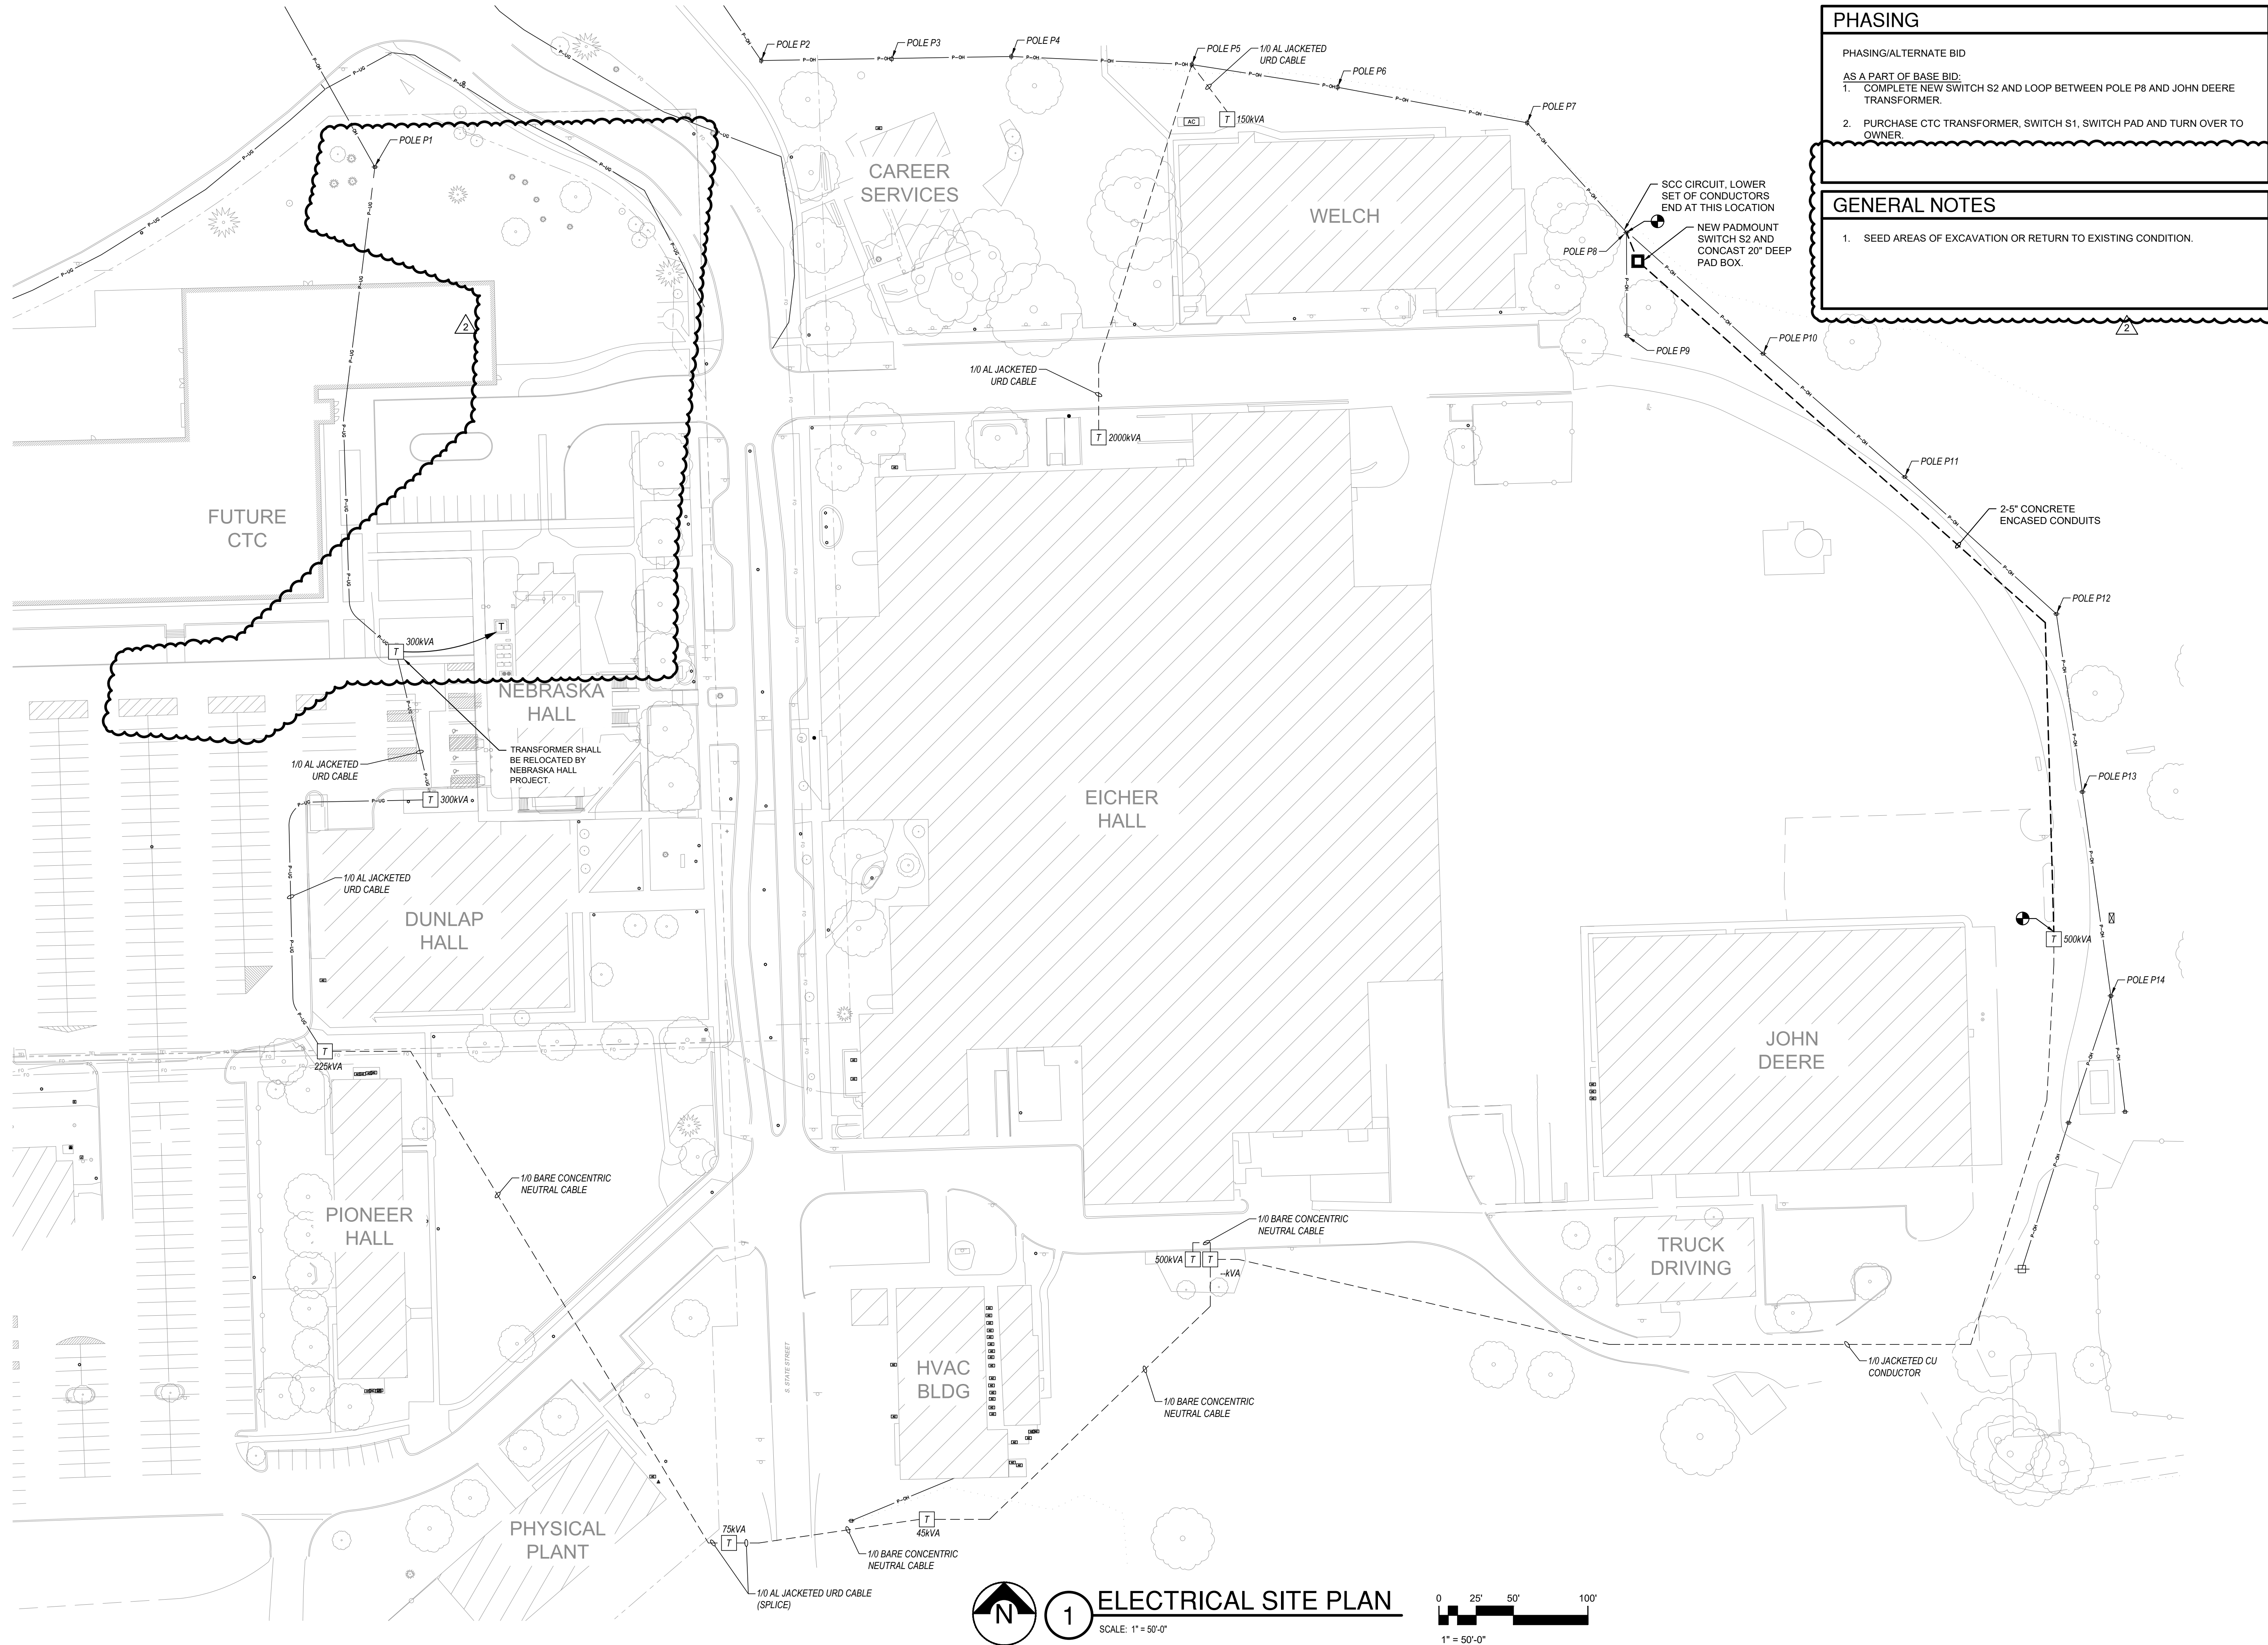

PHASING

PHASING/ALTERNATE BID:
AS A PART OF BASE BID:
1. COMPLETE NEW SWITCH S2 AND LOOP BETWEEN POLE P8 AND JOHN DEERE TRANSFORMER.
2. PURCHASE CTC TRANSFORMER, SWITCH S1, SWITCH PAD AND TURN OVER TO OWNER.

GENERAL NOTES

1. SEED AREAS OF EXCAVATION OR RETURN TO EXISTING CONDITION.

SEAL:

These drawing and the designs here illustrated are the sole property of BranchPattern, Inc. and may not be reproduced in whole or in part without express written permission.

PROJECT TITLE

SOUTHEAST COMMUNITY COLLEGE
MILFORD MEDIUM VOLTAGE LOOP COMPLETION
600 S STATE ST.
MILFORD, NE 68405

rev.	description	date
1	Addendum #1	10/02/2023
2	Add #1 Re-Bid	11/03/2023

DESIGNED BY:
SK

DRAWN BY:
BP




REVIEWED BY:
SK

PROJECT NO.
222006

DATE
10/13/2023

SUBMITTAL LEVEL
RE-BID DOCUMENTS

SHEET TITLE
ELECTRICAL SITE PLAN

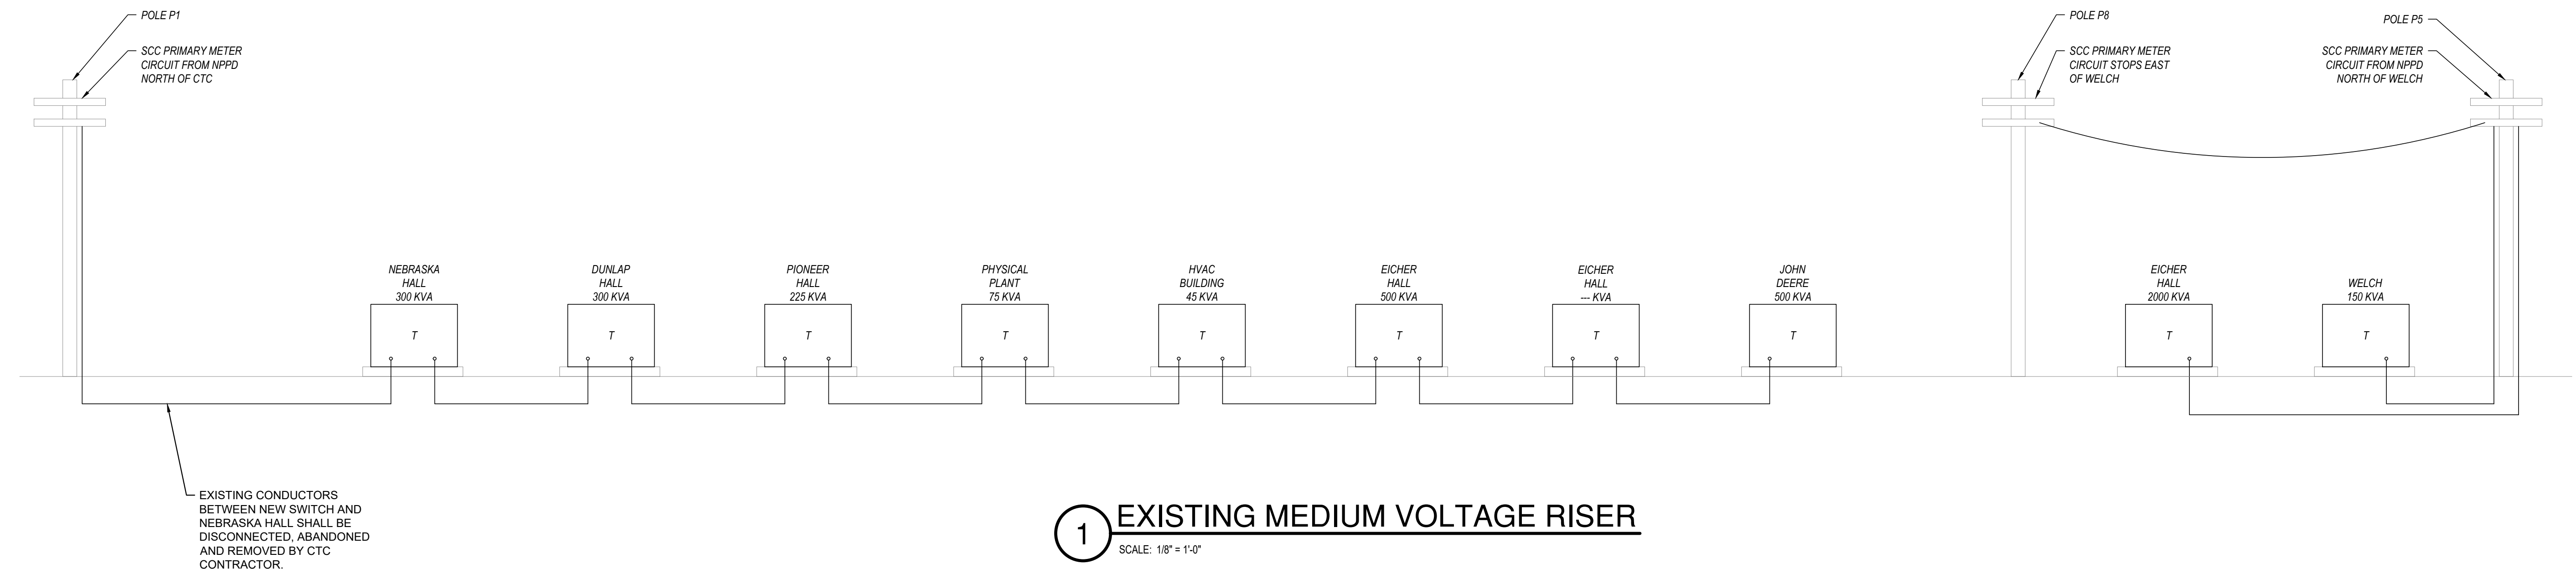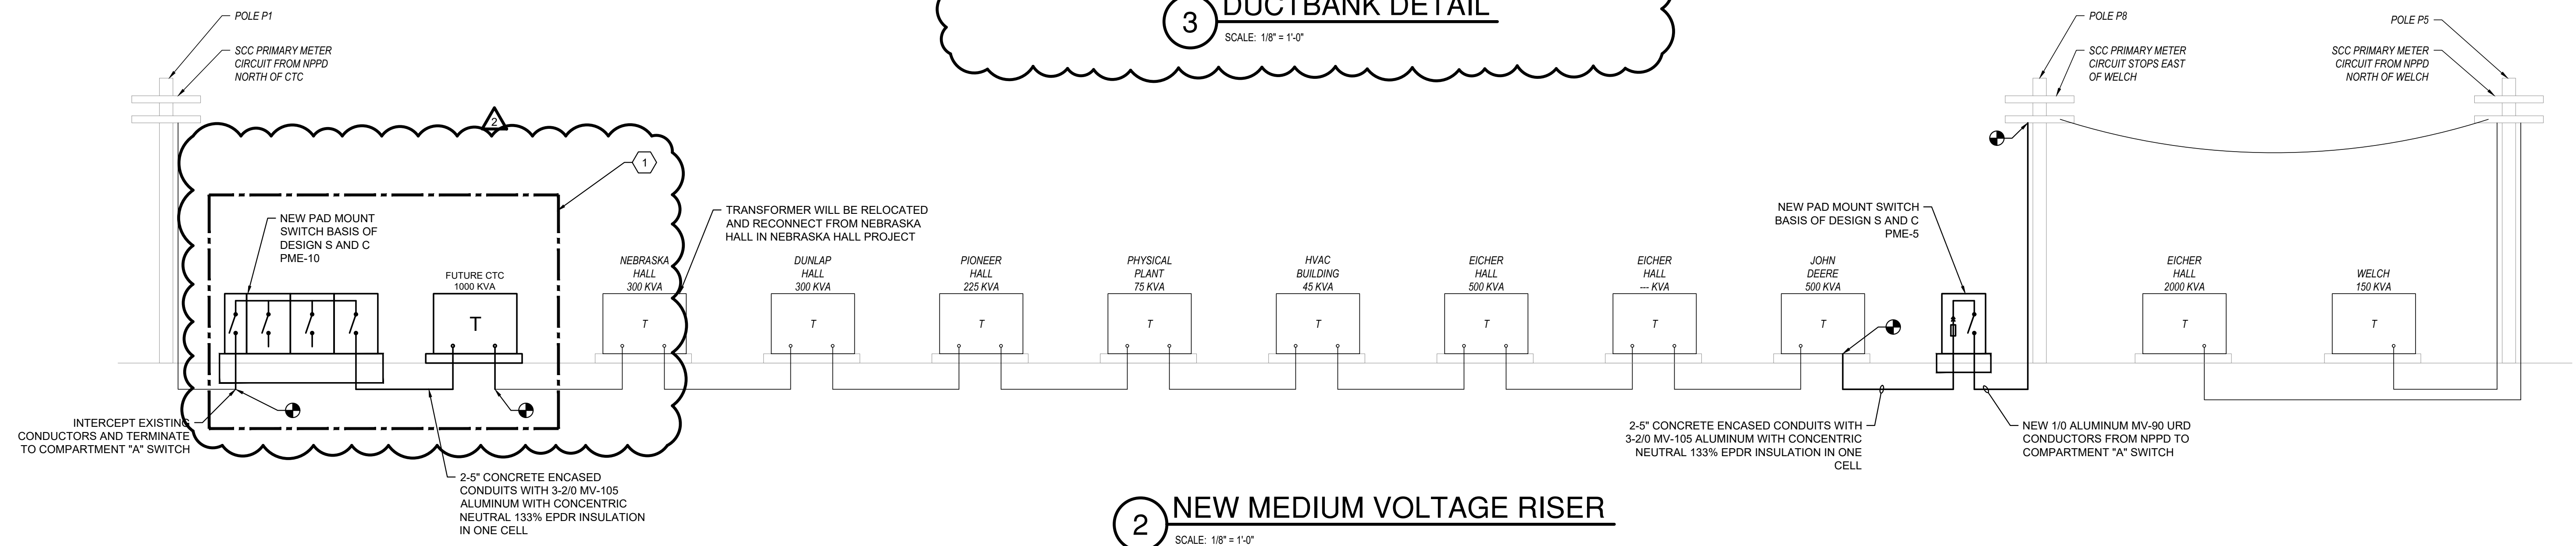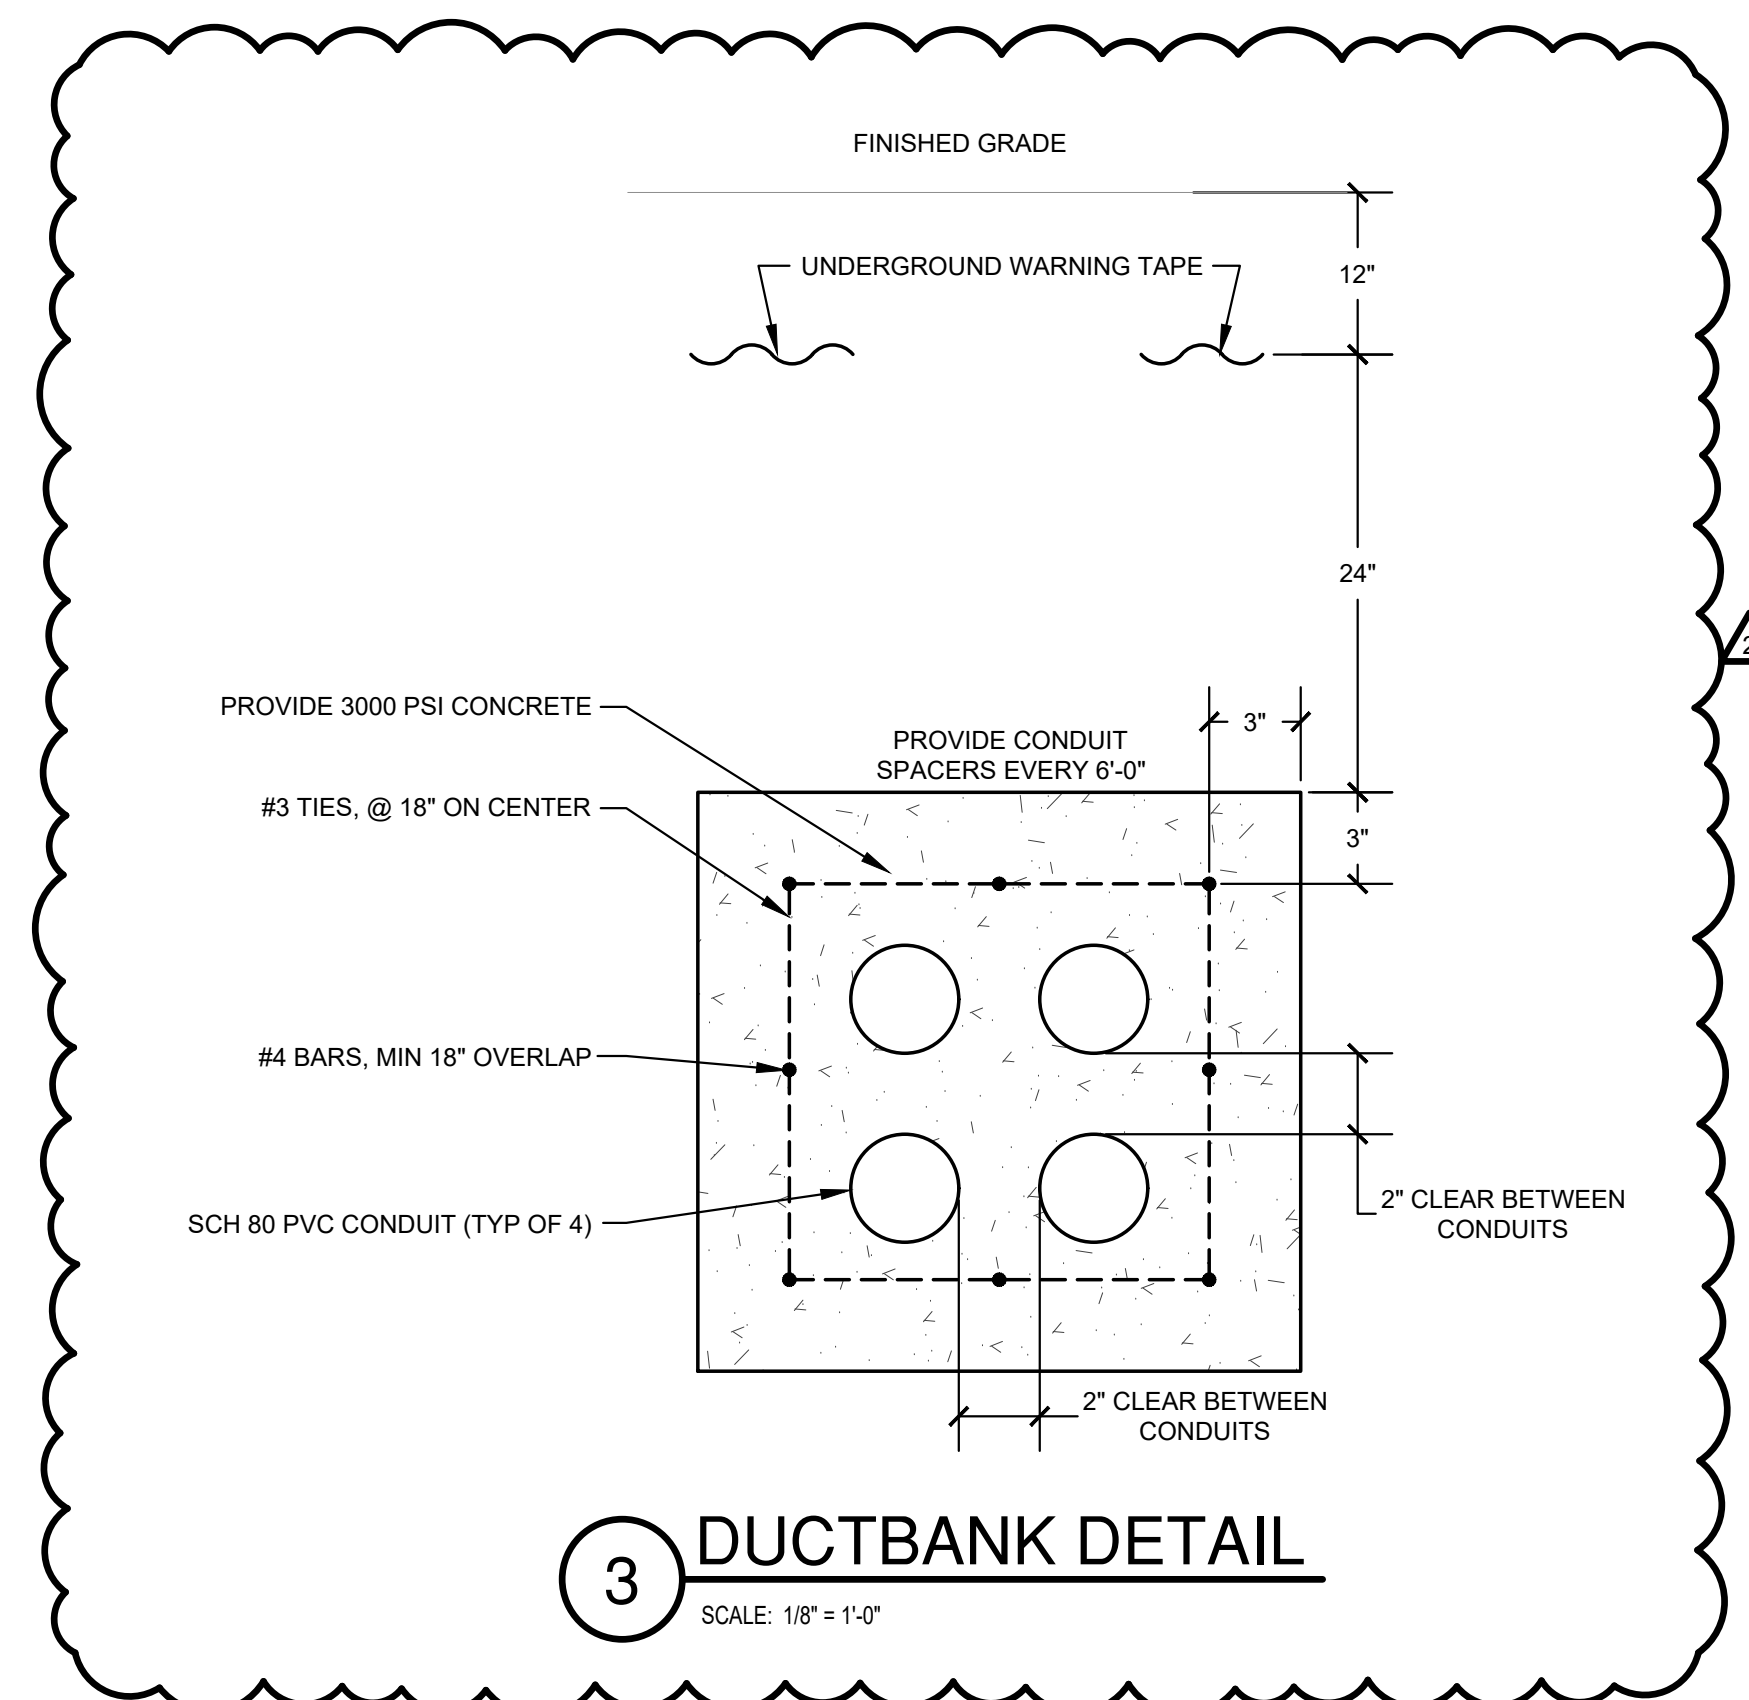

PHASING

PHASING/ALTERNATE BID


AS A PART OF BASE BID:

1. COMPLETE NEW SWITCH S2 AND LOOP BETWEEN POLE P8 AND JOHN DEERE TRANSFORMER.
2. PURCHASE CTC TRANSFORMER, SWITCH S1, SWITCH PAD AND TURN OVER TO OWNER

KEY NOTES

(THIS SHEET)

1. FURNISH EQUIPMENT AS PART OF THIS CONTRACT. INSTALLATION BY FUTURE CONTRACT.

 **BranchPattern**
LINCOLN • OMAHA • KANSAS CITY • DENVER • CHICAGO
PHONE: 1-800-200-9160
www.branchpattern.com
BETTER BUILT ENVIRONMENTS

SEAL:

These drawing and the designs here illustrated are the sole property of BranchPattern, Inc. and may not be reproduced in whole or in part without express written permission.

SOUTHEAST COMMUNITY COLLEGE
MILFORD MEDIUM VOLTAGE LOOP COMPLETION
600 S STATE ST.
MILFORD, NE 68405

PROJECT TITLE

[illegible]

DESIGNED BY:

BP

DRAWN BY:

SK

REVIEWED BY:

SK

PROJECT NO.

222006

DATE _____

10/13/2023

SUBMITTAL LEVEL

RE-BID DOCUMENTS

SHEET TITLE

ELECTRICAL

DETAILS

SHEET NO. _____

E200

© 2023 BRANCHPATTERN, INC.