

# Addendum 2



www.specializedeng.com

---

**Date:** August 23, 2017

**Project Name:** Geneva Youth Rehabilitation and Treatment  
Center Fire Alarm

**Project #:** 16116

---

## General Specification Items:

- GS1. The following manufacturers are approved to bid the project. Approval to bid does not constitute acceptance of the product for use in the building. Final approval must be obtained through the formal shop drawing submittal process. The list is presented by product application and not necessarily by specification reference.
- A. Siemens
  - B. Potter Fire
- GS2. A Fire alarm Contractor is allowed to bid as the Prime Contractor.
- GS3. The Prime Contractor is responsible for all work associated with the project and hiring the appropriate subcontractors.
- GS4. Patch and Paint – The contractor is responsible for patching all demolition to match the wall surface, and painting the entire surface of the wall from corner to corner.
- GS5. The contractor shall provide all passwords and software for the New Fire Alarm System.

## Electrical Drawing Items:

- ED1. Sheet E1-0 Cottage Floor Plans
- A. Add Fire Alarm Annunciator to Sandoz Vestibule
  - B. Clarified Keyed Notes 2 and 8
- ED2. Sheet ES1-0 – Site Plan – Fire Alarm
- A. Added clarification to notes.

---

**Submitted By:** Brad Carne

jlh




**SHEET NOTES:**

- ① CONTROL PANEL SHALL CONTAIN CENTRAL DIALER FOR CAMPUS.
- ② APPROXIMATE LOCATION OF EXISTING POST INDICATOR VALVE. PROVIDE FIRE ALARM MODULE AND CONNECTIONS AS REQUIRED. PROVIDE RIGID CONDUIT ABOVE GRADE.
- ③ PROVIDE (1) ONE NEW PHONE LINE WITH NEW CONDUIT FROM EXISTING CAMPUS MAIN TELECOM ENTRANCE (CONTROL ROOM LOCATED IN THE ADMINISTRATION BUILDING BASEMENT) TO NEW CENTRAL DIALER LOCATION OF THE NEW FIRE ALARM NETWORK. THIS PHONE LINE IS IN ADDITION TO THE EXISTING PHONE LINE ALREADY SERVING THE EXISTING DIALER IN BURROUGHS. RECONNECT THE EXISTING PHONE LINE TO THE NEW DIALER AS WELL. ROUTING SHOWN FOR DIAGRAMMATIC PURPOSES ONLY. ON THE NORTH SIDE OF THE COTTAGES, THERE ARE EXISTING COMMUNICATIONS AND FIBER LINES. CONTRACTOR SHALL FIELD VERIFY LOCATIONS OF COMMUNICATIONS AND FIBER LINES PRIOR TO BORING. COORDINATE EXACT ROUTING WITH FACILITY REPRESENTATIVE PRIOR TO WORK.
- ④ CONTRACTOR SHALL FIELD VERIFY EXACT LOCATION OF MAIN PHONE ROOM AT THE PRE-BID WALKTHRU.
- ⑤ APPROXIMATE ROUTE FOR CONTRACTOR PROVIDED FIRE ALARM NETWORK UNDERGROUND LOOP.

**GENERAL NOTES:**

- 1. SANDOZ AND BURROUGHS COTTAGES CEILINGS ARE GYPSUM CONSTRUCTION. SACAJAWEA COTTAGE CEILING IS A.C.T. 2x4 CEILING. THE CONTRACTOR SHALL BE RESPONSIBLE TO RECTIFY ANY DAMAGE TO BUILDING MATERIALS WITH EQUAL IN TERMS OF QUANTITY, QUALITY, AND OTHER CHARACTERISTICS.
- 2. CONTRACTOR SHALL LOCATE ALL EXISTING UNDERGROUND UTILITIES WITHIN AREA OF WORK TO WORK AROUND EXISTING INFRASTRUCTURE. NPPD WILL NOT LOCATE ON THE SITE. CONTRACTOR IS RESPONSIBLE FOR ALL UTILITY LOCATION IN BID.
- 3. CONTRACTOR SHALL BORE ALL NEW UNDERGROUND PATHWAYS. THERE SHALL BE NO REMOVAL OF CONCRETE SIDEWALKS, DRIVES, OR PARKING AREAS.
- 4. BORING SHALL COME INTO BASEMENT AREAS OF BUILDINGS. NO CONDUIT SHALL BE MOUNTED TO THE EXTERIOR OF BUILDINGS.

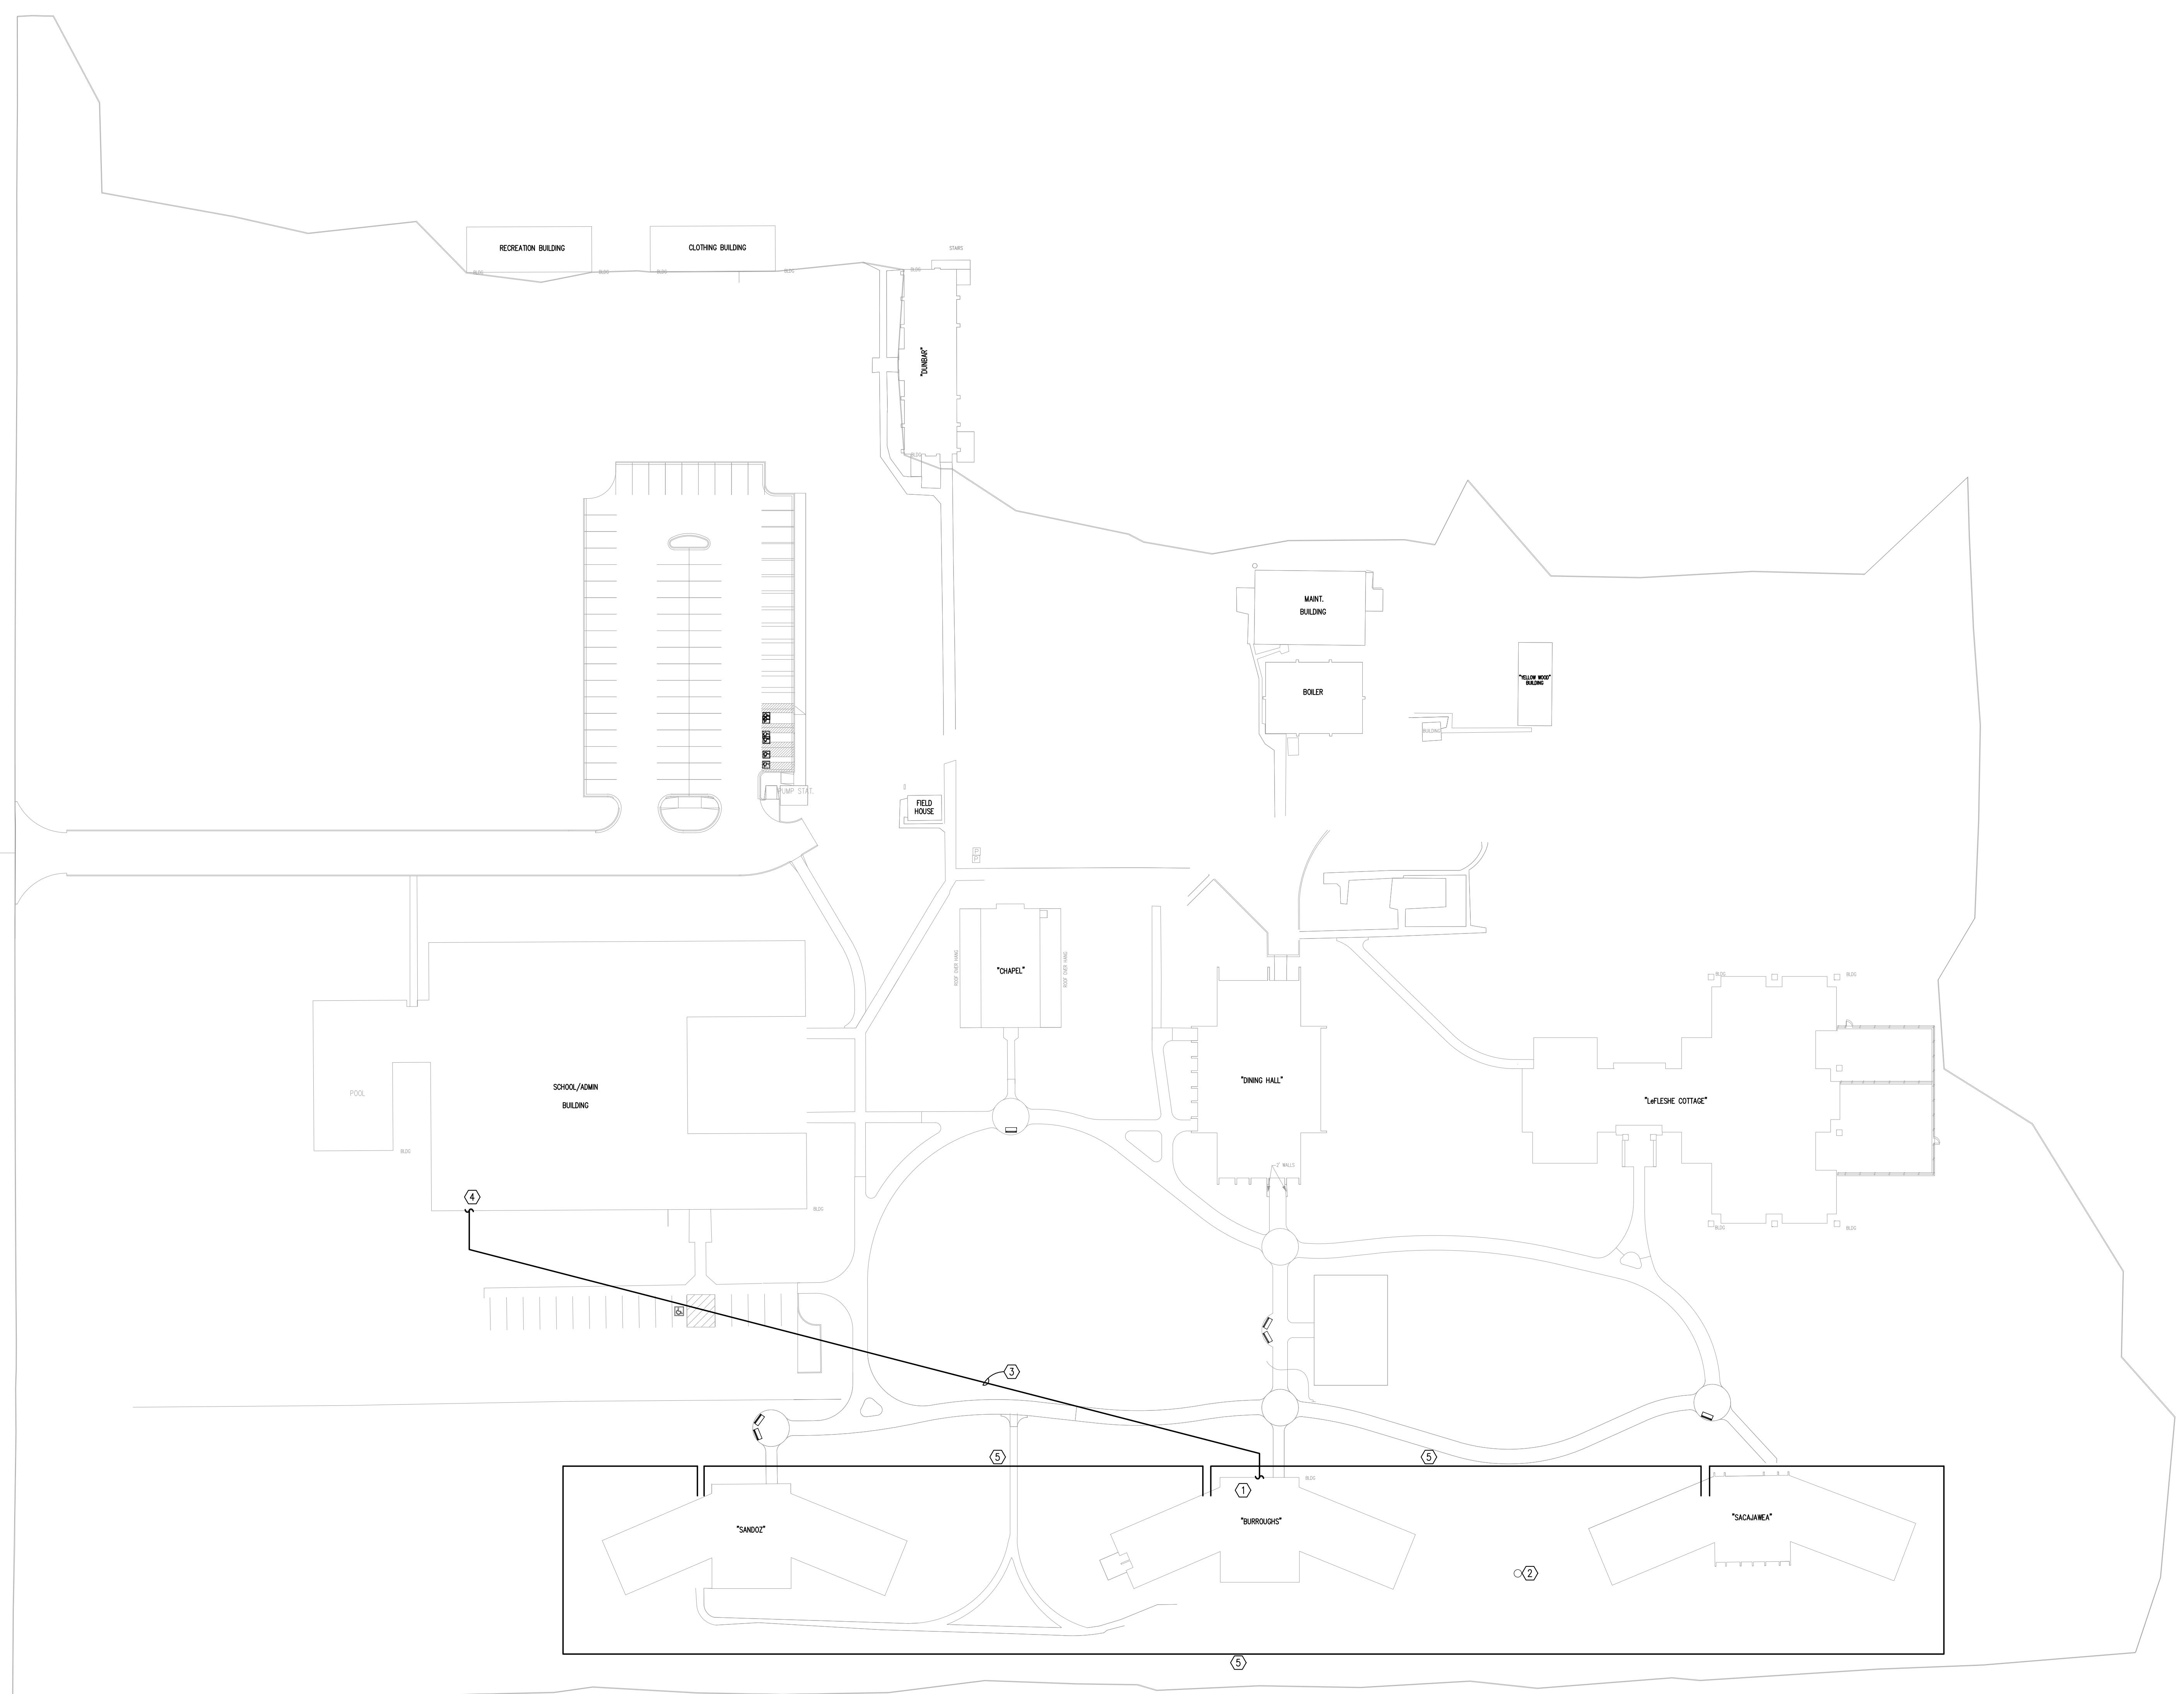

ADDENDUM #2	2017-08-22
No.	Revisions/Submissions
Date	

Job Title  
**GENEVA YOUTH REHAB TREATMENT CENTER  
COTTAGE FIRE ALARM UPGRADE**

2016 © COPYRIGHT  
PERMISSION TO REPRODUCE ANY PART OF THIS DOCUMENT IS HEREBY GRANTED SOLELY FOR THE PURPOSE OF THE CONSTRUCTION OF THE PROJECT OR THE ARCHIVING OF THIS PROJECT. UNAUTHORIZED USE OF THIS DOCUMENT WITHOUT THE WRITTEN PERMISSION OF SPECIALIZED ENGINEERING SOLUTIONS IS PROHIBITED BY COPYRIGHT LAW.


DO NOT SCALE DRAWING. ALL DIMENSIONS AND CLEARANCES SHALL BE VERIFIED FROM APPROPRIATE SOURCES. ALL WORK SHALL BE COORDINATED PRIOR TO INSTALLATION. SEE SPECIFICATIONS.

Drawing Title  
**SITE PLAN - FIRE ALARM**

Drawn	KCK	Project No.	16116
Designed	ACR	Scale	1"=10'-0"
Reviewed	KSB	Date	08/01/2017
Drawing No.	<b>ES1-0</b>		

**GENEVA YOUTH REHABILITATION TREATMENT CENTER - SITE PLAN**

SCALE: 1" = 40' - 0"

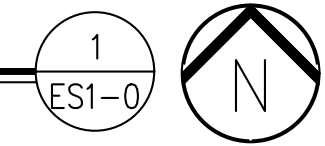

2017-08-22 10:00 AM  
 C:\Users\jacob\OneDrive\Documents\Geneva Youth Rehab\Geneva Youth Rehab\Site Plan - Fire Alarm\ES1-0.dwg  
 Jacob K. K...  
 10/2/2017 10:00 AM